


CALCULATED SITE PLAN SUBSTATION 3

CONSTRUCTION NOTES

- ELECTRICAL VAULT, SEE ELECTRICAL PLANS FOR ADDITIONAL INFORMATION.
- ELECTRICAL EQUIPMENT, SEE ELECTRICAL AND STRUCTURAL PLANS FOR ADDITIONAL INFORMATION.
- CHAIN LINK FENCE, SEE ARCHITECTURAL PLANS FOR ADDITIONAL INFORMATION.
- CONTRACTOR TO CONSTRUCT NEW CONCRETE FLATWORK SUCH THAT FLATWORK DOES NOT ENCROUGH INTO LIGHT POLE BASE.
- CONTRACTOR TO CONSTRUCT KEYING CONCRETE SLAB TO MATCH EXISTING CURB AND GUTTER, SEE THIS SHEET FOR DETAILS

LEGEND

- CONCRETE FLATWORK
4" P.C.C. WITH WIRE MESH (6X6X10GA.) OVER 4" CLASS II A.B. (MECHANICALLY COMPACTED TO 92% R.C.) OVER 12" SUBGRADE (90% R.C.) SEE THIS SHEET FOR DETAILS
- STRUCTURAL CONCRETE
12" P.C.C. SEE STRUCTURAL DRAWING SHEET S2.1 FOR REINFORCEMENT AND SUBGRADE INFORMATION

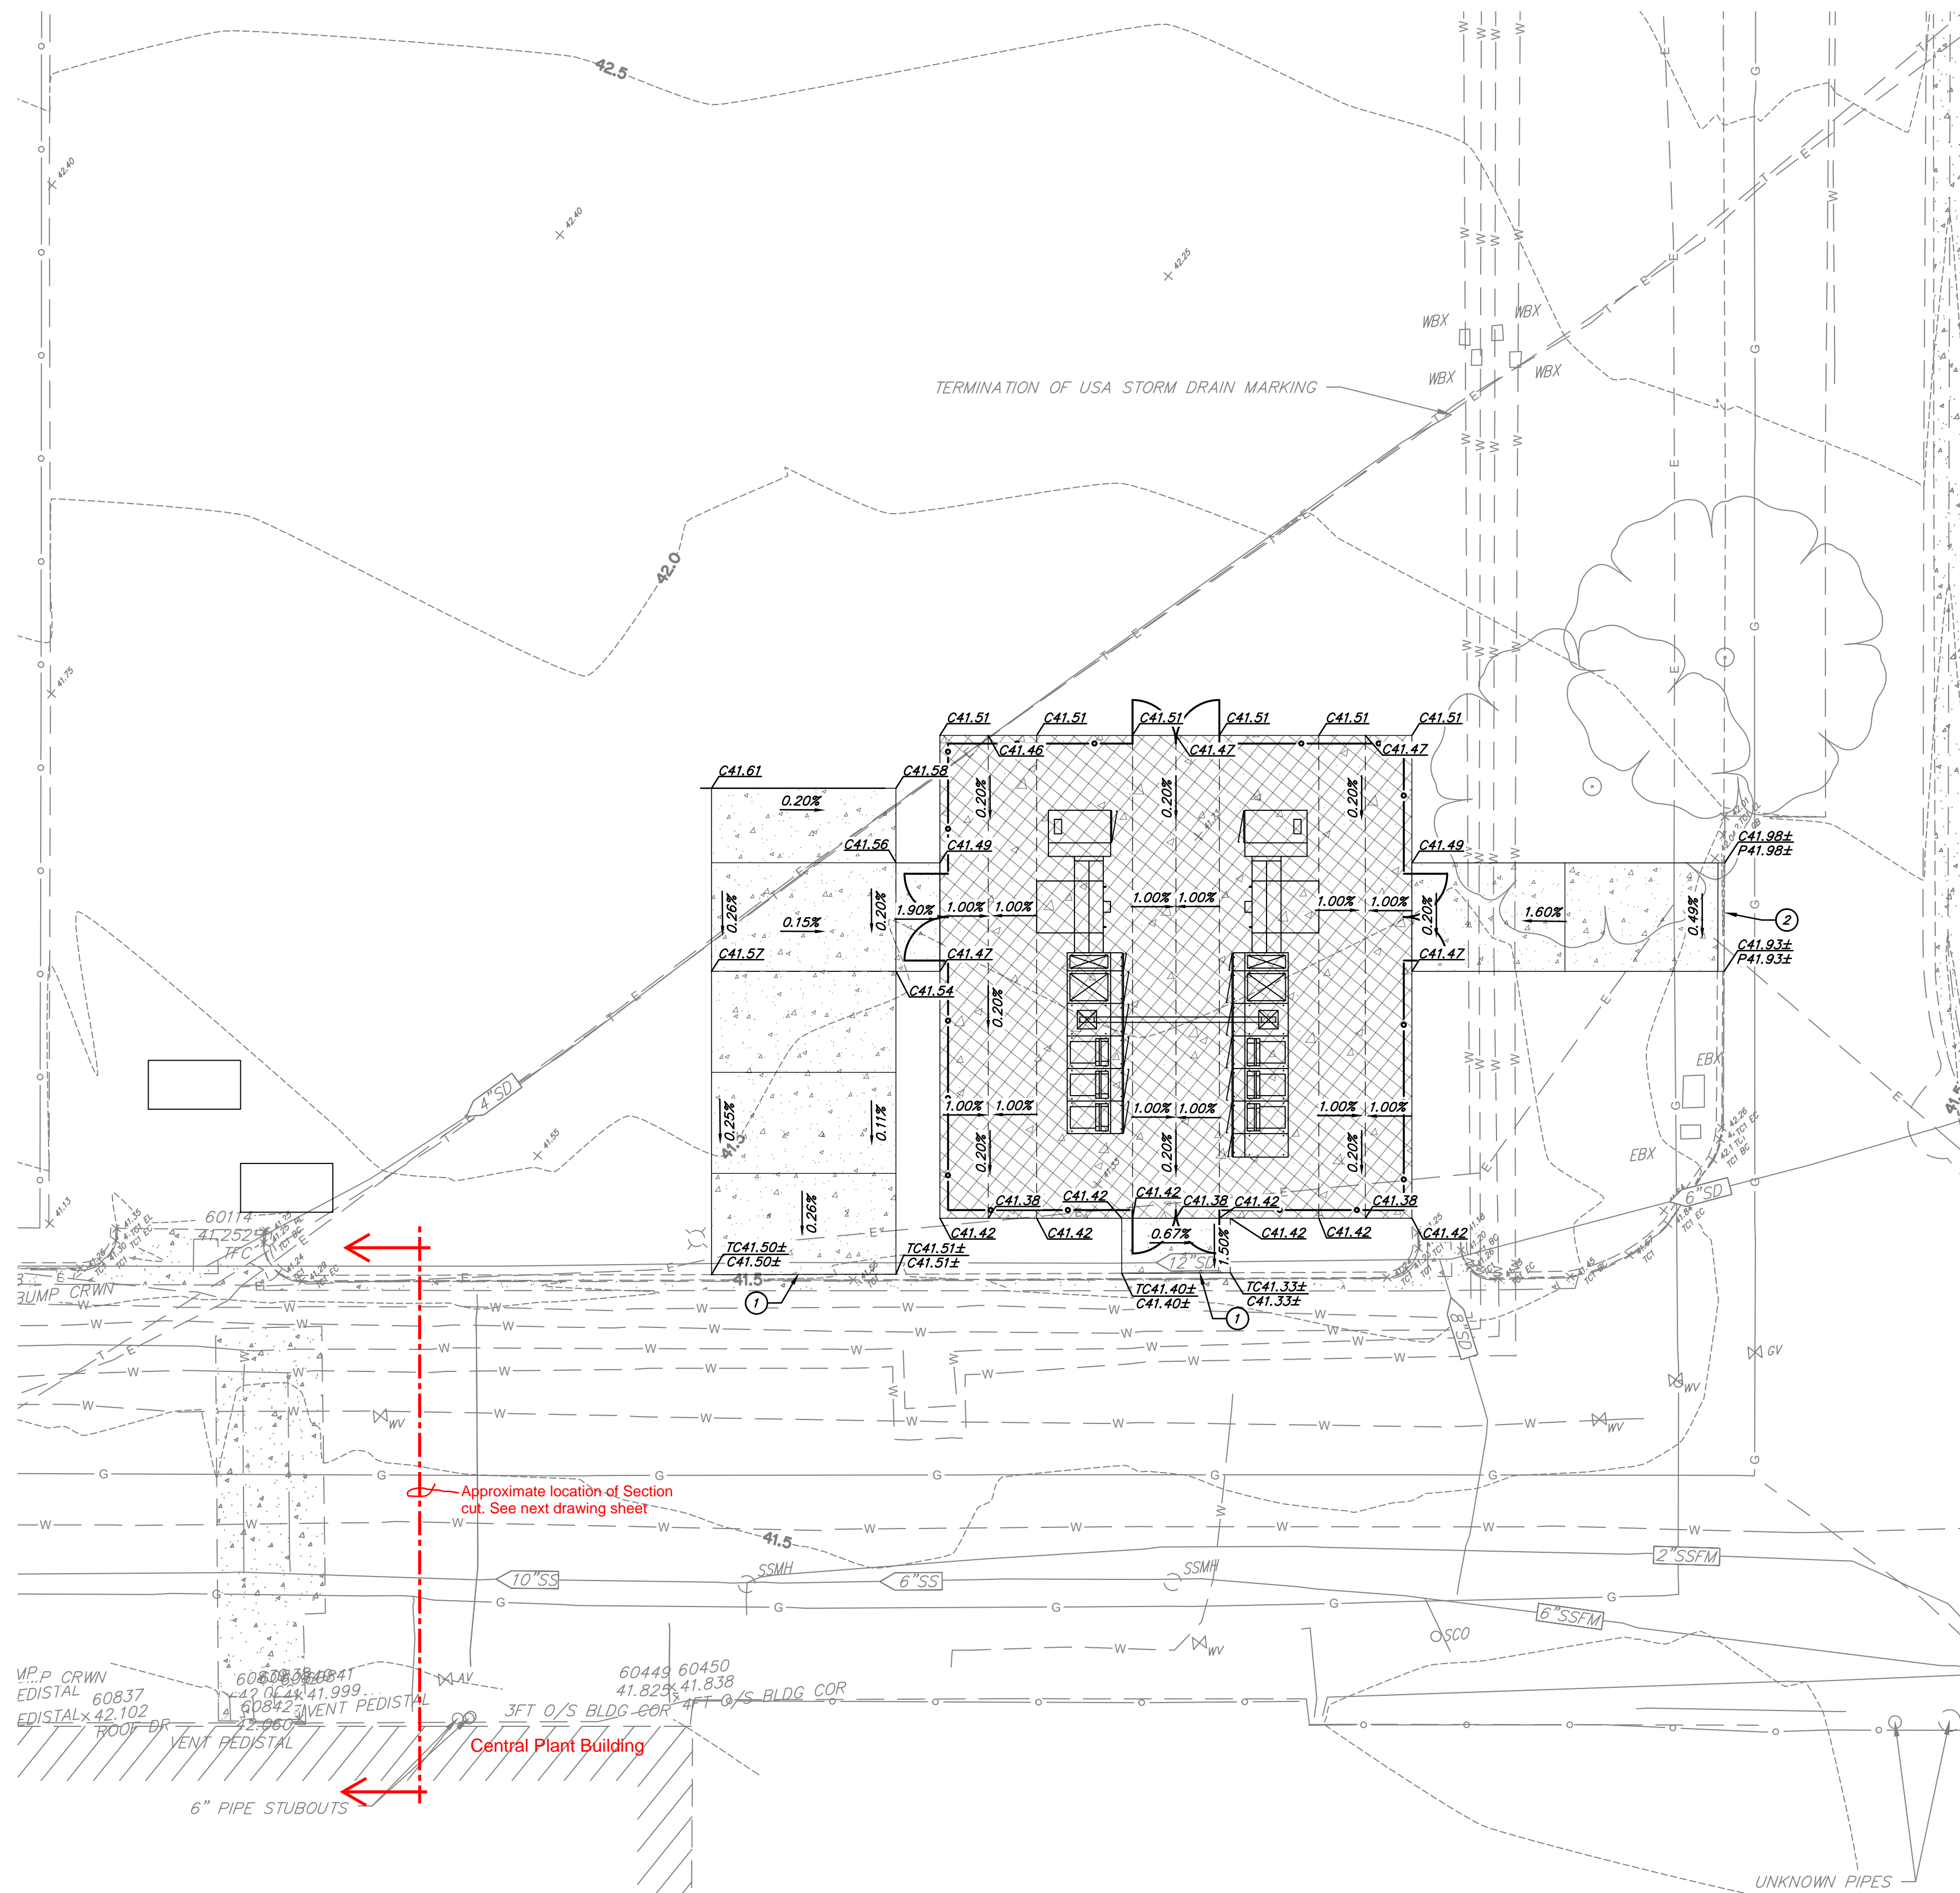




ARCHITECHNICA

555 West Benjamin Holt Drive, Suite 423
Stockton, California 95207
P: (209) 952-5850
F: (209) 952-2442
E: hello@architechnica.net

www.architechnica.net

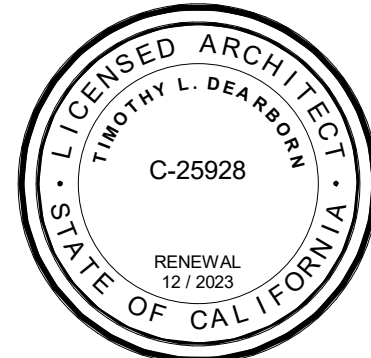

© 2023 ARCHITECHNICA



FEHR ENGINEERING
90578 Soquel Drive, Suite G
Aptos, CA 95003
P: (831) 786-0373
F: (831) 786-8523
E: tpinkerton@fehrengineering.com

CONSULTANT



SUBSTATION #3 & #4 REPLACEMENT

4000 SUISUN VALLEY RD
FAIRFIELD, CA 94534

SOLANO COMMUNITY
COLLEGE DISTRICT

REVISIONS	

PROJECT NO: 2023-03
ISSUE SET: CCD 02
ISSUE DATE: 09/19/23
DRAWN BY: TLD

TRENCH DETAILS

RA1.4

